


ST. JOHNS RIVER POWER PARK
 JACKSONVILLE ELECTRIC AUTHORITY/FLORIDA POWER & LIGHT
 TECHNICAL SERVICES

DESIGN:	SCALE: NONE	DATE:
DRAWN:	DRAWING NUMBER:	REV:
CHKD:		
DR. CK. AP. APRVD:		

NO.	DATE	REVISION

2

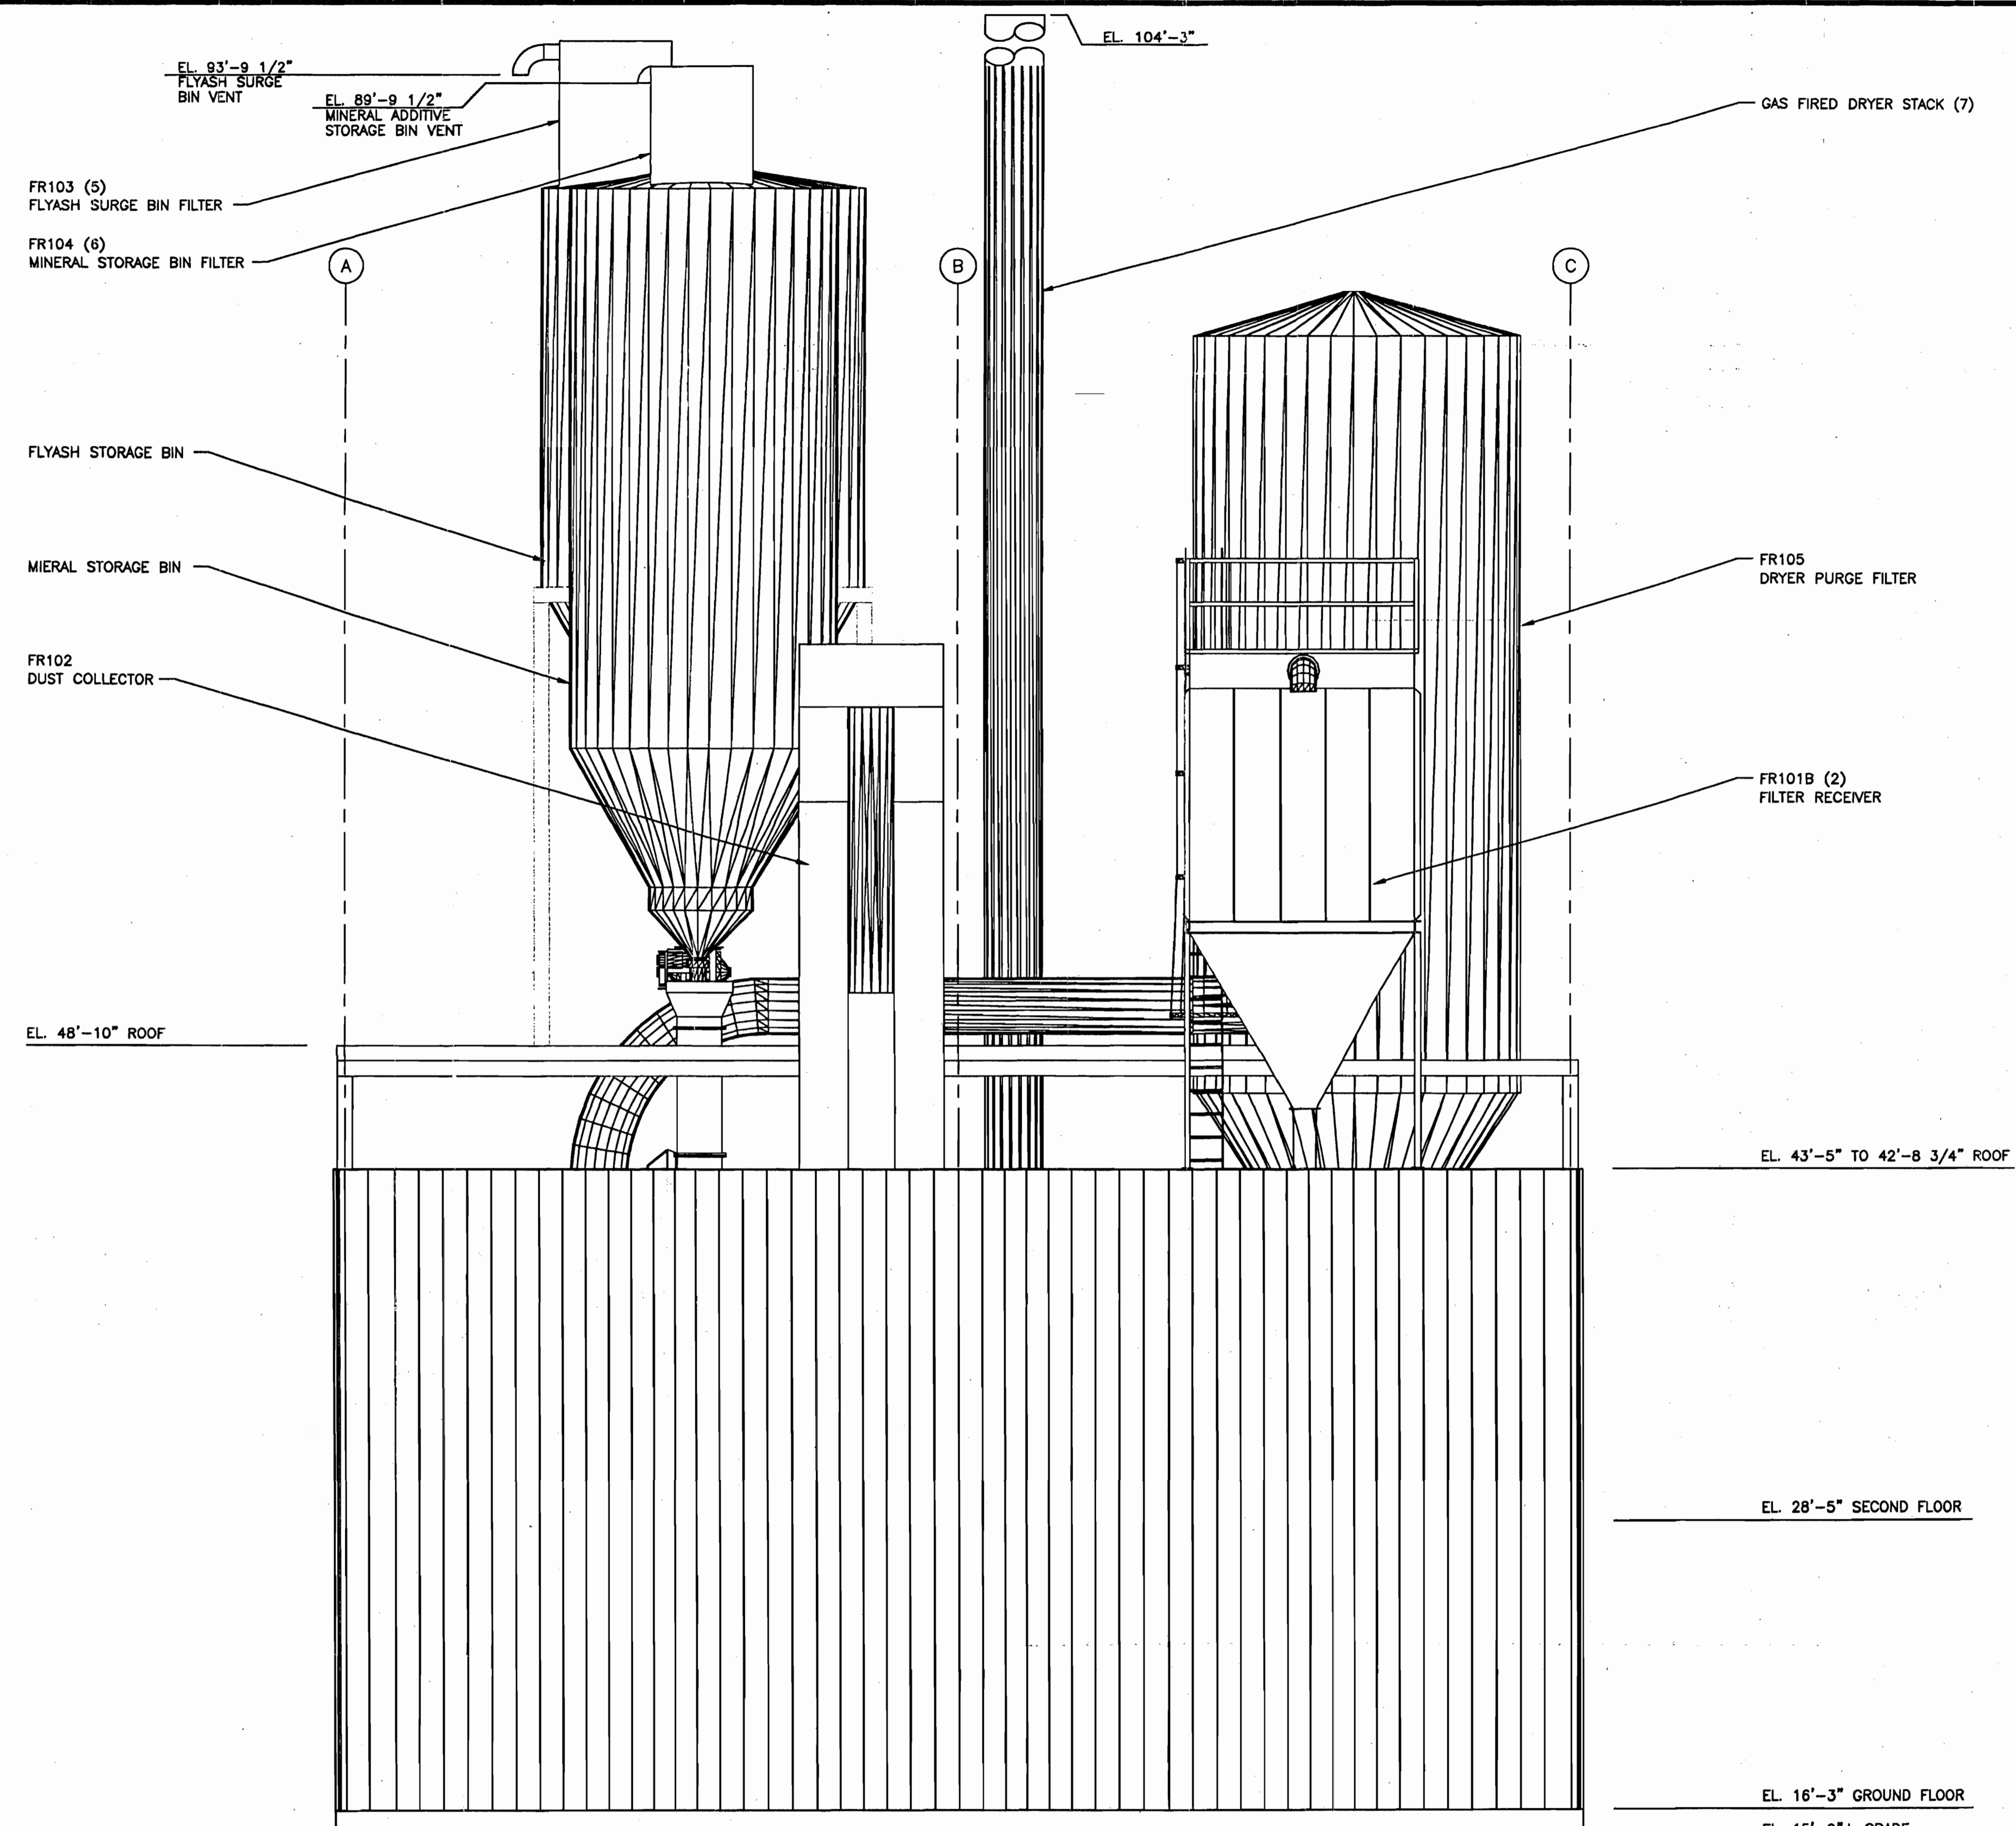

1 WEST ELEVATION (LOOKING EAST)
 1/4" = 1'-0"

9/24/99
 PRELIMINARY

NOTE:
 THE NUMBER ASSOCIATED WITH EQUIPMENT
 DESIGNATIONS INDICATE EMISSION POINTS.


REV.	DATE	BY	DESCRIPTION	APPD.

LAUREN
 Engineers, Inc.
 901 South First Street, Agrest, TX 75602
 (409) 666-4466 Fax (409) 666-8673

PROJECT:
 FLY ASH SEPARATION PROJECT
 JACKSONVILLE ELECTRIC AUTHORITY
 ST. JOHNS RIVER POWER PARK
 SEPARATION TECHNOLOGIES, INC.

DRAWING TITLE:
 PROCESS BUILDING /
 AMMONIA REMOVAL AREA
 WEST ELEVATION

DRAWN: RWB	JOB NO. 9929
CHECKED: JLC	DATE: 9/8/99
SCALE: 1/4" = 1'-0"	2 of 3
DRAWING NO. D-9929-PR3	

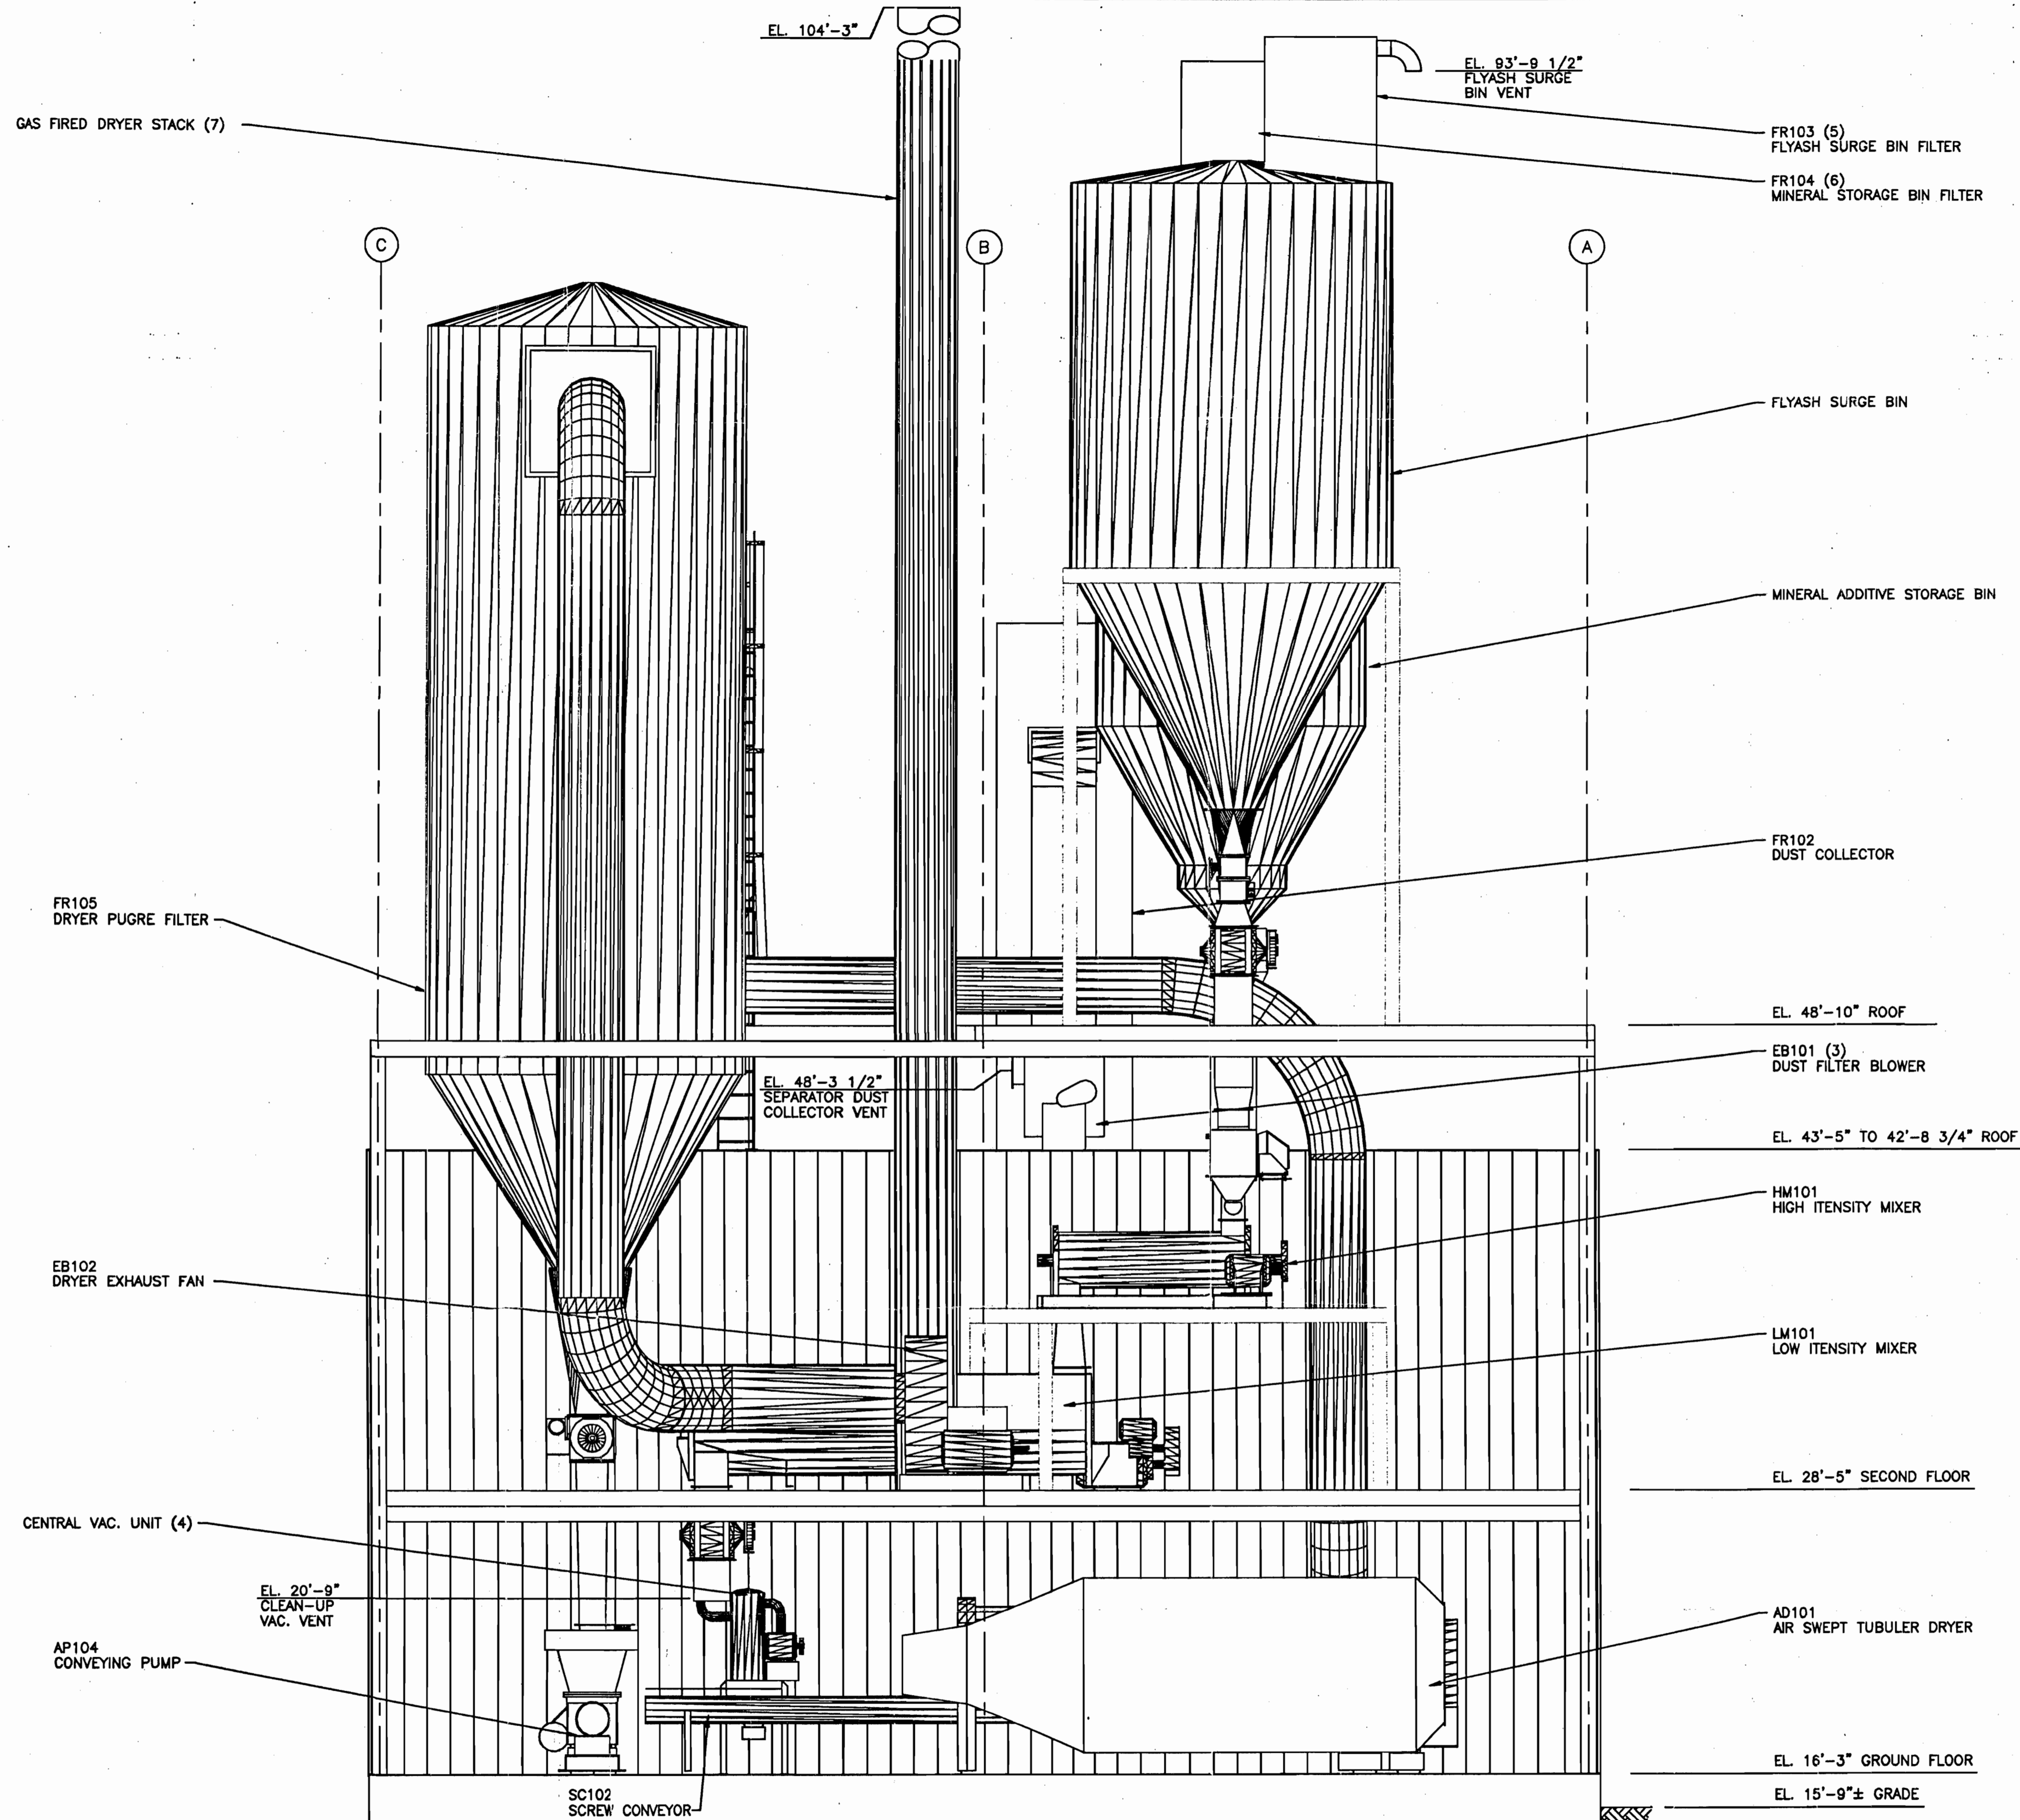

NOTE: THE NUMBER ASSOCIATED WITH EQUIPMENT DESIGNATIONS INDICATE EMISSION POINTS.

9/24/99

PRELIMINARY

1 EAST ELEVATION (LOOKING WEST)
EQS/EQS 1/4"=1'-0"

REV	DATE	BY	DESCRIPTION	APPD.


LAUREN
Engineers, Inc.
901 South First Street, Abilene, TX 79602
(817) 670-4900 Fax (817) 670-9077

PROJECT: FLY ASH SEPARATION PROJECT
JACKSONVILLE ELECTRIC AUTHORITY
ST. JOHNS RIVER POWER PARK
SEPARATION TECHNOLOGIES, INC.

DRAWING TITLE: PROCESS BUILDING /
AMMONIA REMOVAL AREA
EAST ELEVATION

DRAWN: RWB	JOB NO. 9929
CHECKED: JLC	DATE: 9/8/99
SCALE: 1/4"=1'-0"	3 of 3
DRAWING NO. D-9929-PR4	

4

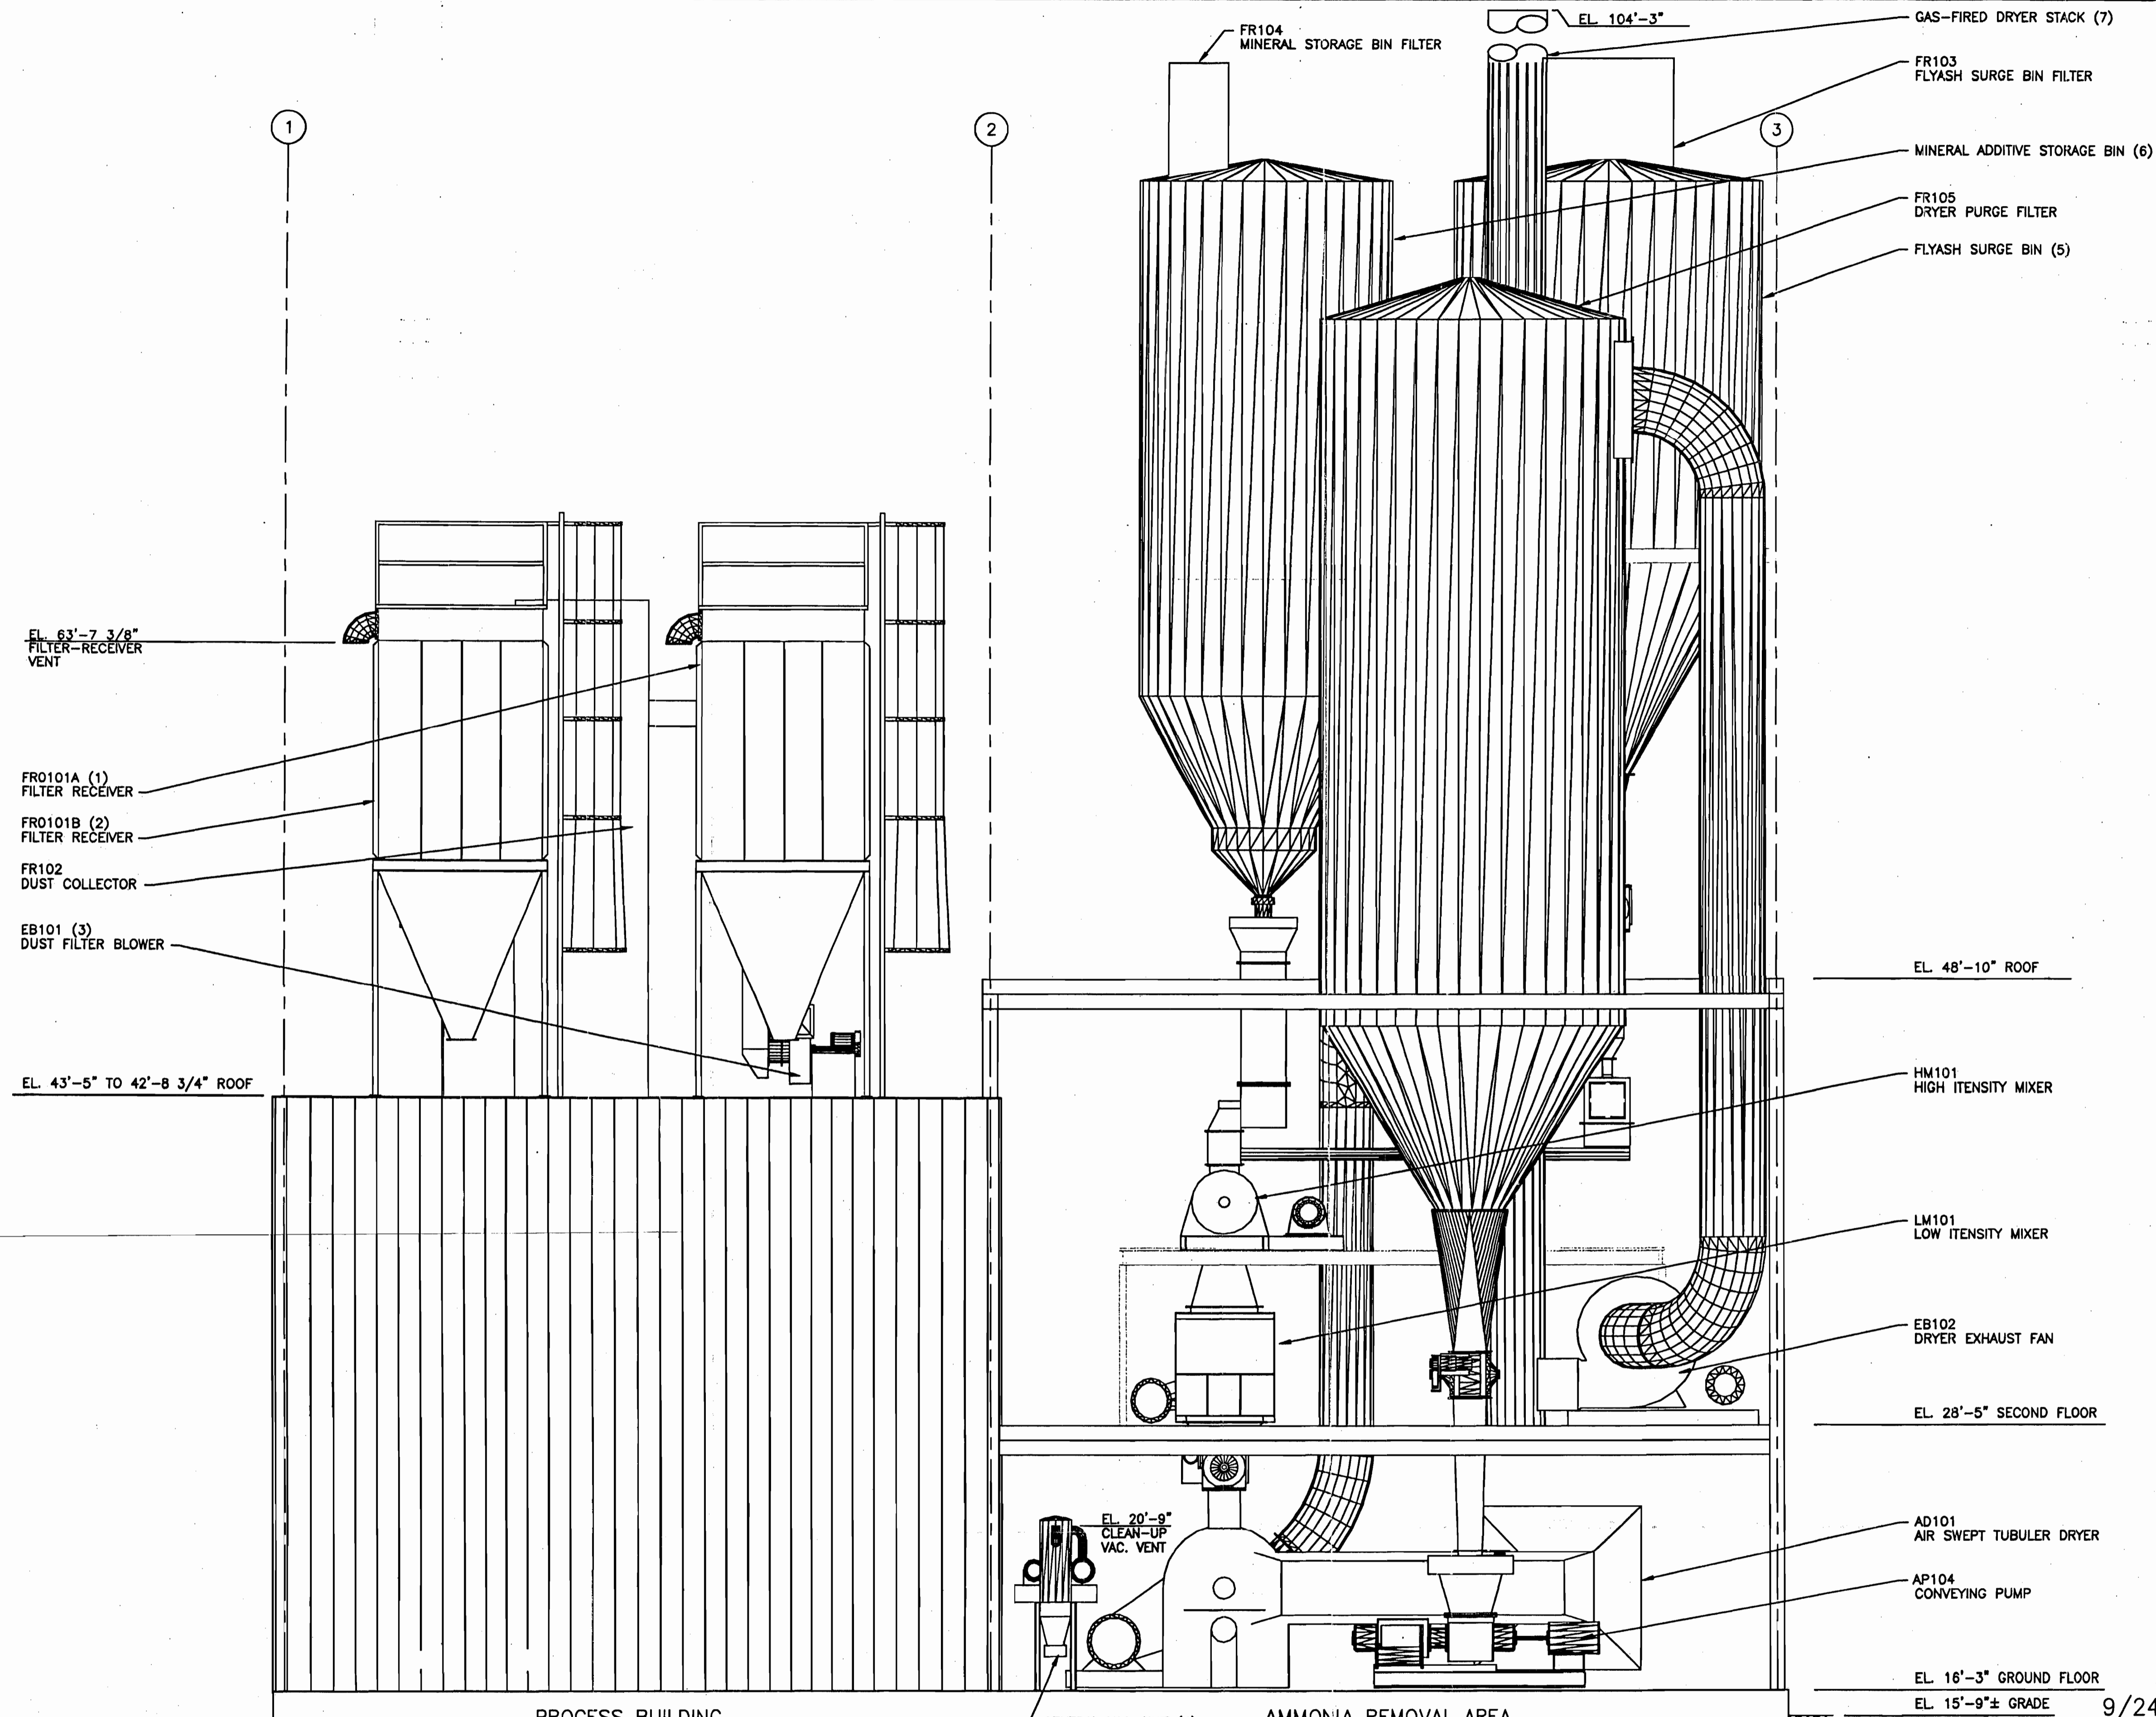

NOTE:
THE NUMBER ASSOCIATED WITH EQUIPMENT
DESIGNATIONS INDICATE EMISSION POINTS.

PROCESS BUILDING

AMMONIA REMOVAL AREA

1 SOUTH ELEVATION (LOOKING NORTH)
1/4"=1'-0"

EL. 16'-3" GROUND FLOOR
EL. 15'-9"± GRADE 9/24/99

PRELIMINARY

REV	DATE	BY	DESCRIPTION	APPD.

LAUREN
Engineers, Inc.
901 South First Street, Abilene, TX 79602
(817) 670-9600

PROJECT:
FLY ASH SEPARATION PROJECT
JACKSONVILLE ELECTRIC AUTHORITY
ST. JOHNS RIVER POWER PARK
SEPARATION TECHNOLOGIES, INC.

DRAWING TITLE:
PROCESS BUILDING /
AMMONIA REMOVAL AREA
SOUTH ELEVATION

DRAWN: RWB	JOB NO. 9929	1 of 3
CHECKED: JLC	DATE: 9/8/99	
SCALE: 1/4"=1'-0"		
DRAWING NO. D-9929-PR2		